


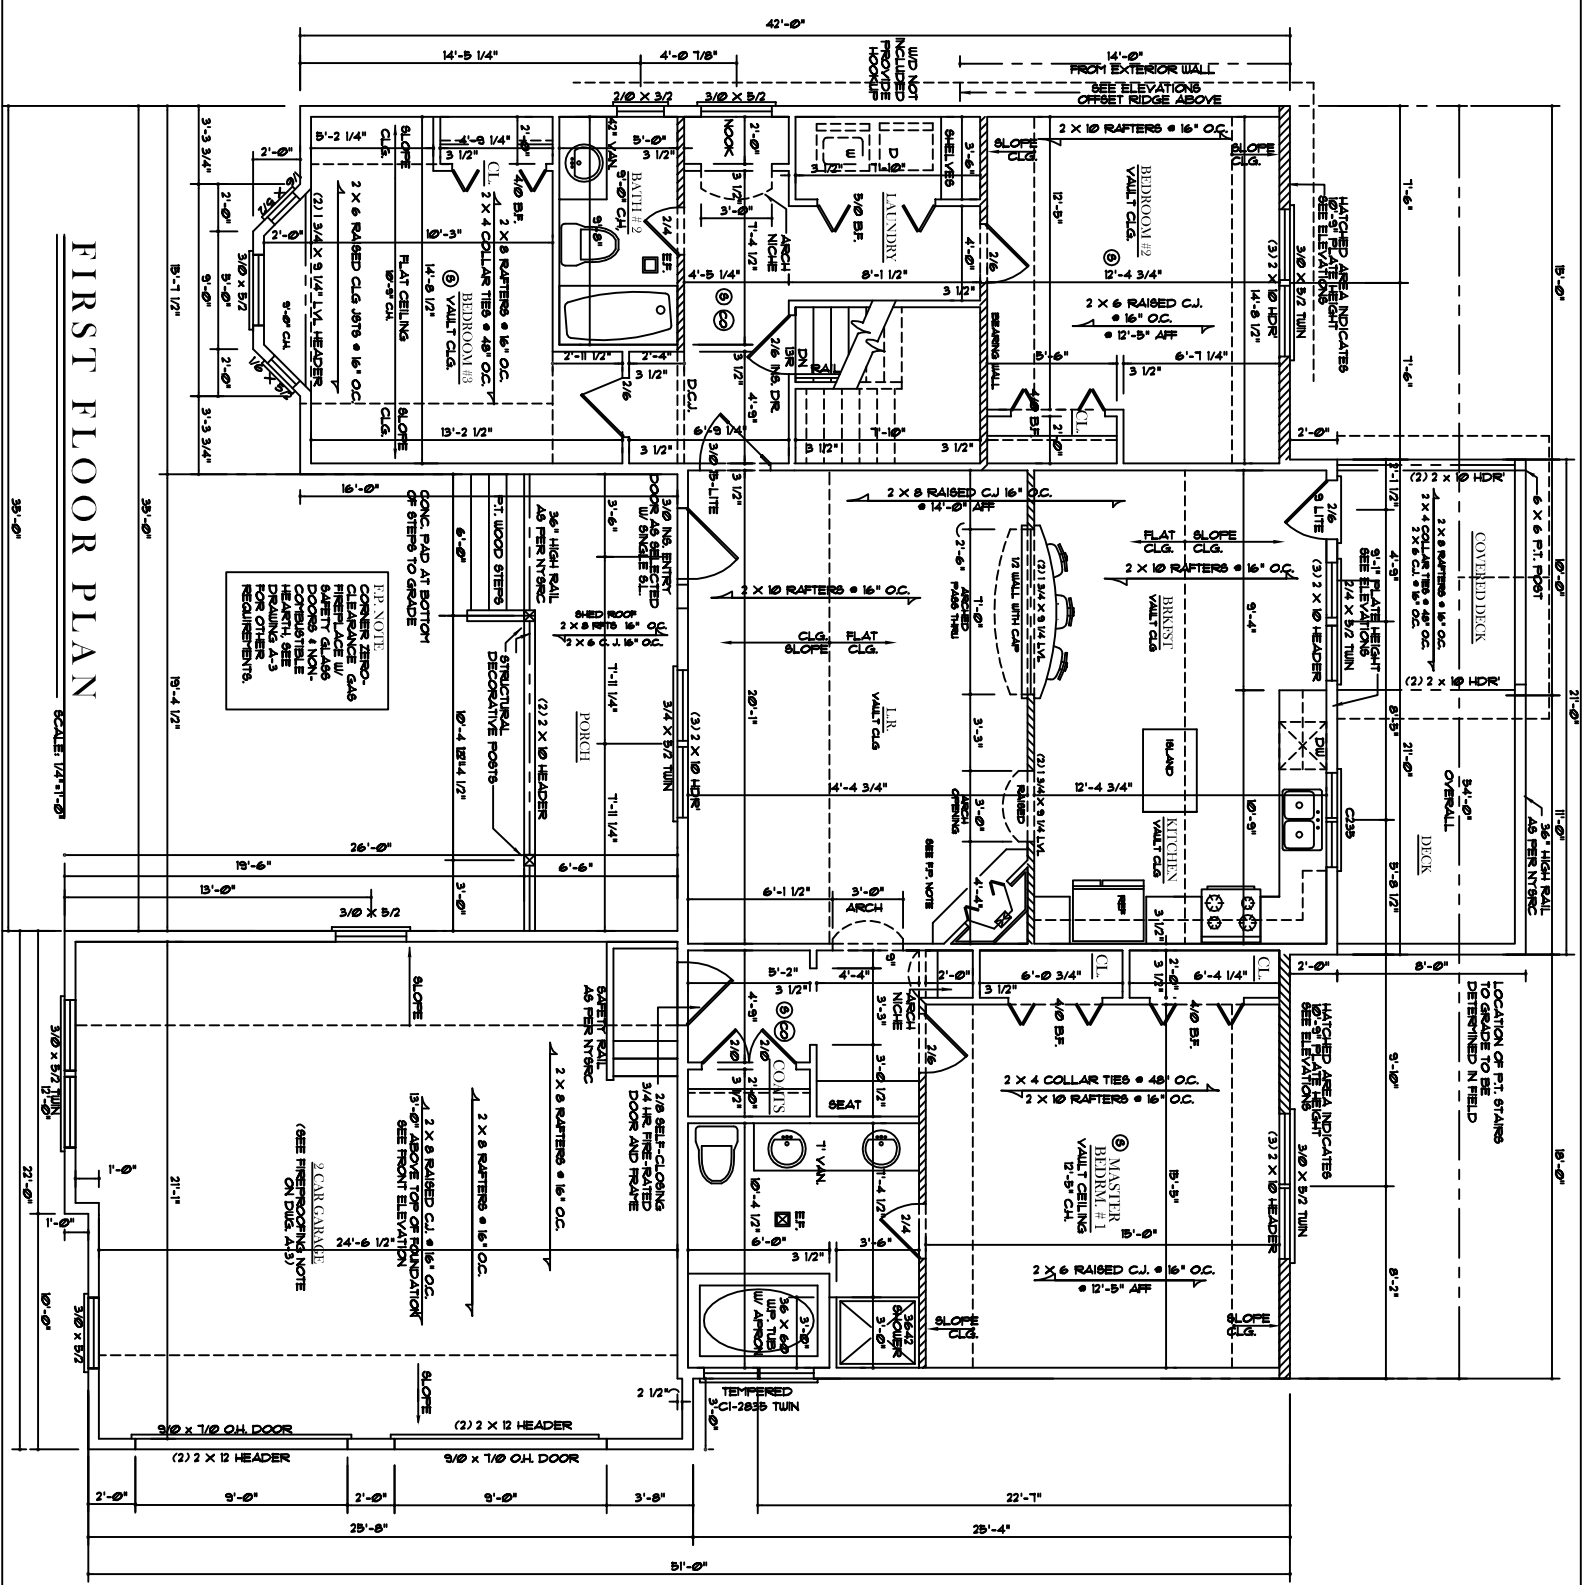

FIRST FLOOR PLAN

SCALE: 1/4"=1'-0"

NOTE (C): CARBON MONOXIDE
INSTALL AS PER INSTRUCTIONS
ALERT

NOTE (D): SMOKE DETECTOR
ALL SMOKE DETECTORS TO BE HARD
WIRED AND INTER-CONNECTED AND
HAVE BATTERY BACKUP
SINGLE FAMILY T - RANCH
SQUARE FOOTAGE
FIRST FLOOR - 1650 SQ. FT.
TOTAL - 1750 SQ. FT.

NOTE - DETECTOR VENTS
GARAGE
• 8" DIA. VENT
• 12" DIA. VENT

DIAGNOSTIC VENTS FROM CLOTHES DRESSERS
SHALL BE VENTED TO THE EXTERIOR
IN ACCORDANCE WITH THE DETECTOR
MANUFACTURER'S INSTRUCTIONS
VENT ON EXTERIOR OF BUILDING EQUIPPED
WITH A BACKDRAFT DAMPER EXHAUST
DUCTS SHALL BE CONSTRUCTED OF MINIMUM
6" DIA. THICK (1/2" MIN) RIGID METAL
DUCTS. SHALL BE INSULATED TO PREVENT
CONDENSATION. DETECTOR VENTS SHALL
SHALL NOT EXCEED 25 FEET. IF LENGTH
EXCEEDS 25', A BOOSTER FAN SHALL BE
PROVIDED. INSTALL AS PER MANUFACTURER'S
INSTRUCTIONS.

BLADES
MAKANLAND
DEV. LLC

MODEL:
THE STONEBROOK

JOB LOCATION:
BRACOFF SUBDIVISION
VIO AVENUE
GRANDE COUNTY, NY

DATE:
JULY 2009

SCALE:
NOTED

DRAWN BY:
RJA/P

Drago
Architects
Design & Planning
Consultants

201 WARD STREET, SUITE J
MONTICOMERY, NY 12549
(845) 457-3752

SHEET NO.:
A-51R
OF 7